


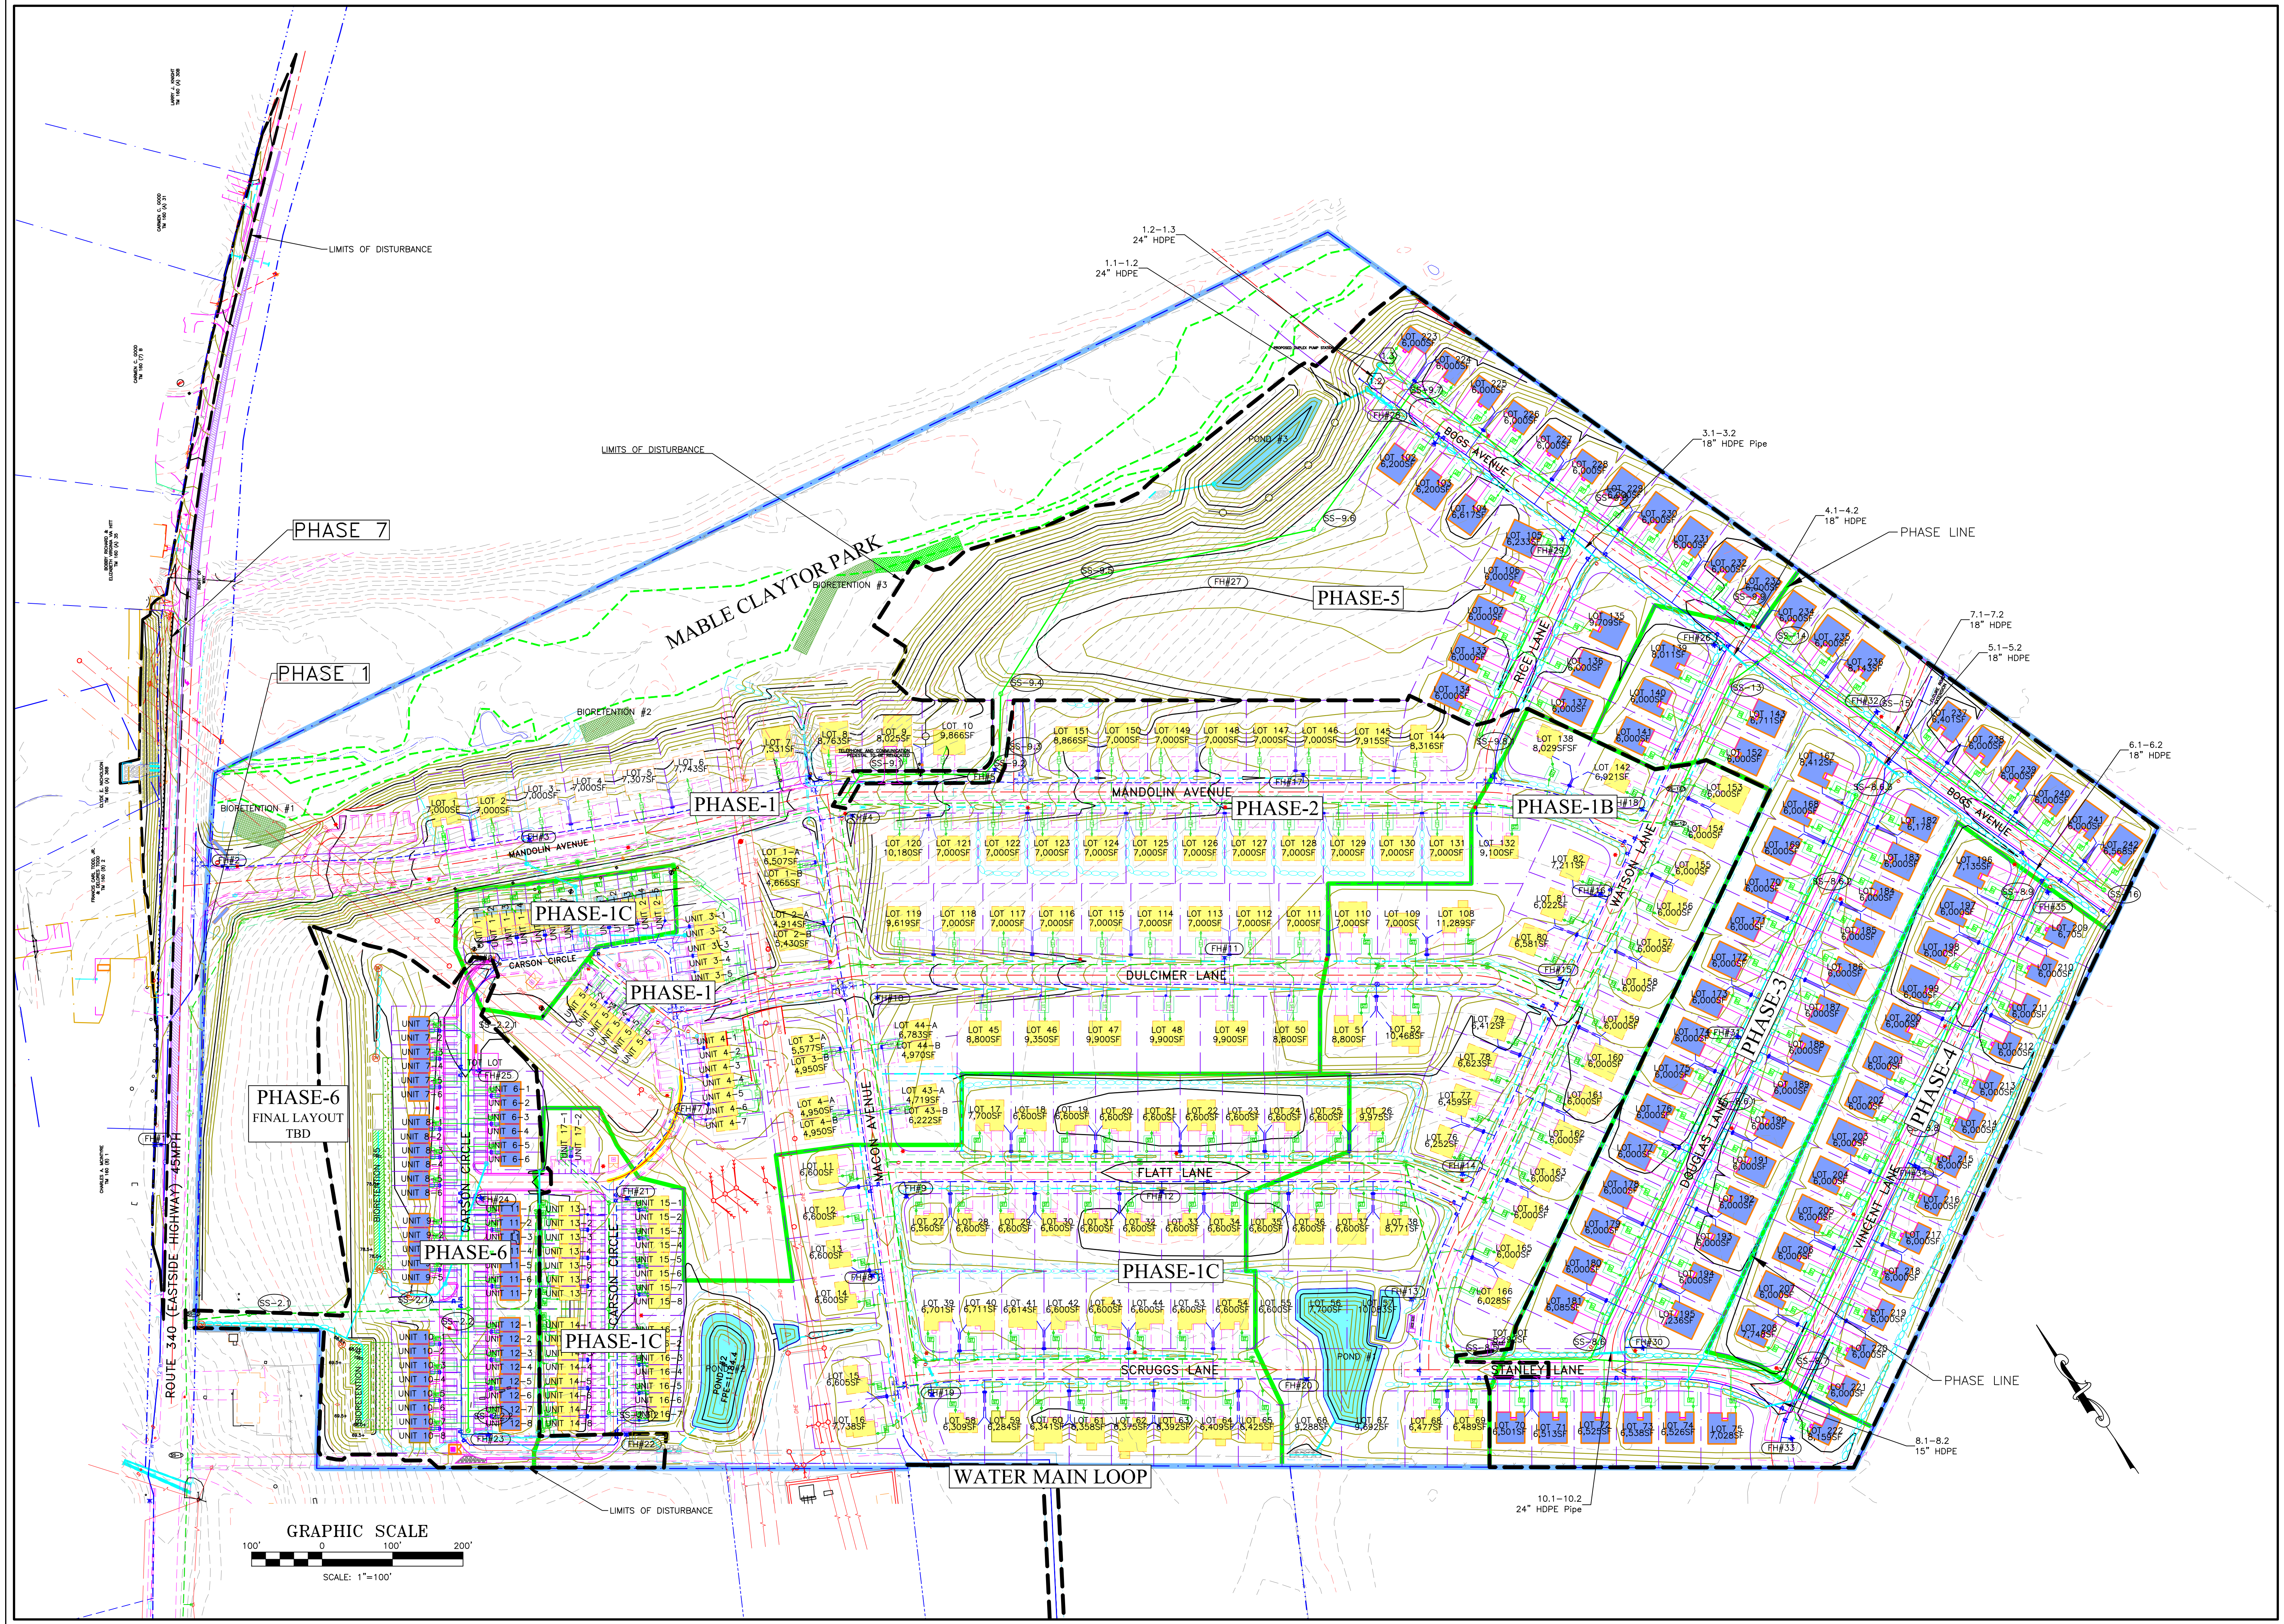

Date: Sept. 3, 2021

Scale: 1"=100'

Designed by: NHK

Drawn by: NHK

Checked by: JRC

Blackwell Engineering

A Trademark of AES Consulting Engineers

566 East Market Street

Harrisonburg, Virginia 22801

Phone: (540) 432-9555

COMMONWEALTH OF VIRGINIA

NATHAN HUNTER KNOPP

Lic. No. 0402060274

6/30/2023

PROFESSIONAL ENGINEER

Revision Dates

11/30/2021

2/24/2022

4/29/2022 VDOT

5/13/2022 TOWNHOMES

6/30/2023 VDOT

SITE PLAN

SHADY CREEK SUBDIVISION (3, 4, 5, 6, 7)

ROB LYNCH

PO BOX 503

RUCKERSVILLE, VA 22968

Drawing No.

3

of 24 Sheets

Job No.

2016-04